


REV.	DESCRIPTION	DATE	DWN BY	CHK'D BY	APP'D BY	REV.	MINE	LEVEL	
							114 OB	80L	
							SUBJECT Mine Rescue		
							SCALE 1" = 100'	DRAWN BY rjteddy	CREATION DATE 04/07/2015
							FILENAME VIEW_COPY_OF_V_22_114_0080.vdcl		

**VALE** ONTARIO OPERATIONS  
MINES ENGINEERING DEPARTMENT

CHK'D APP'D

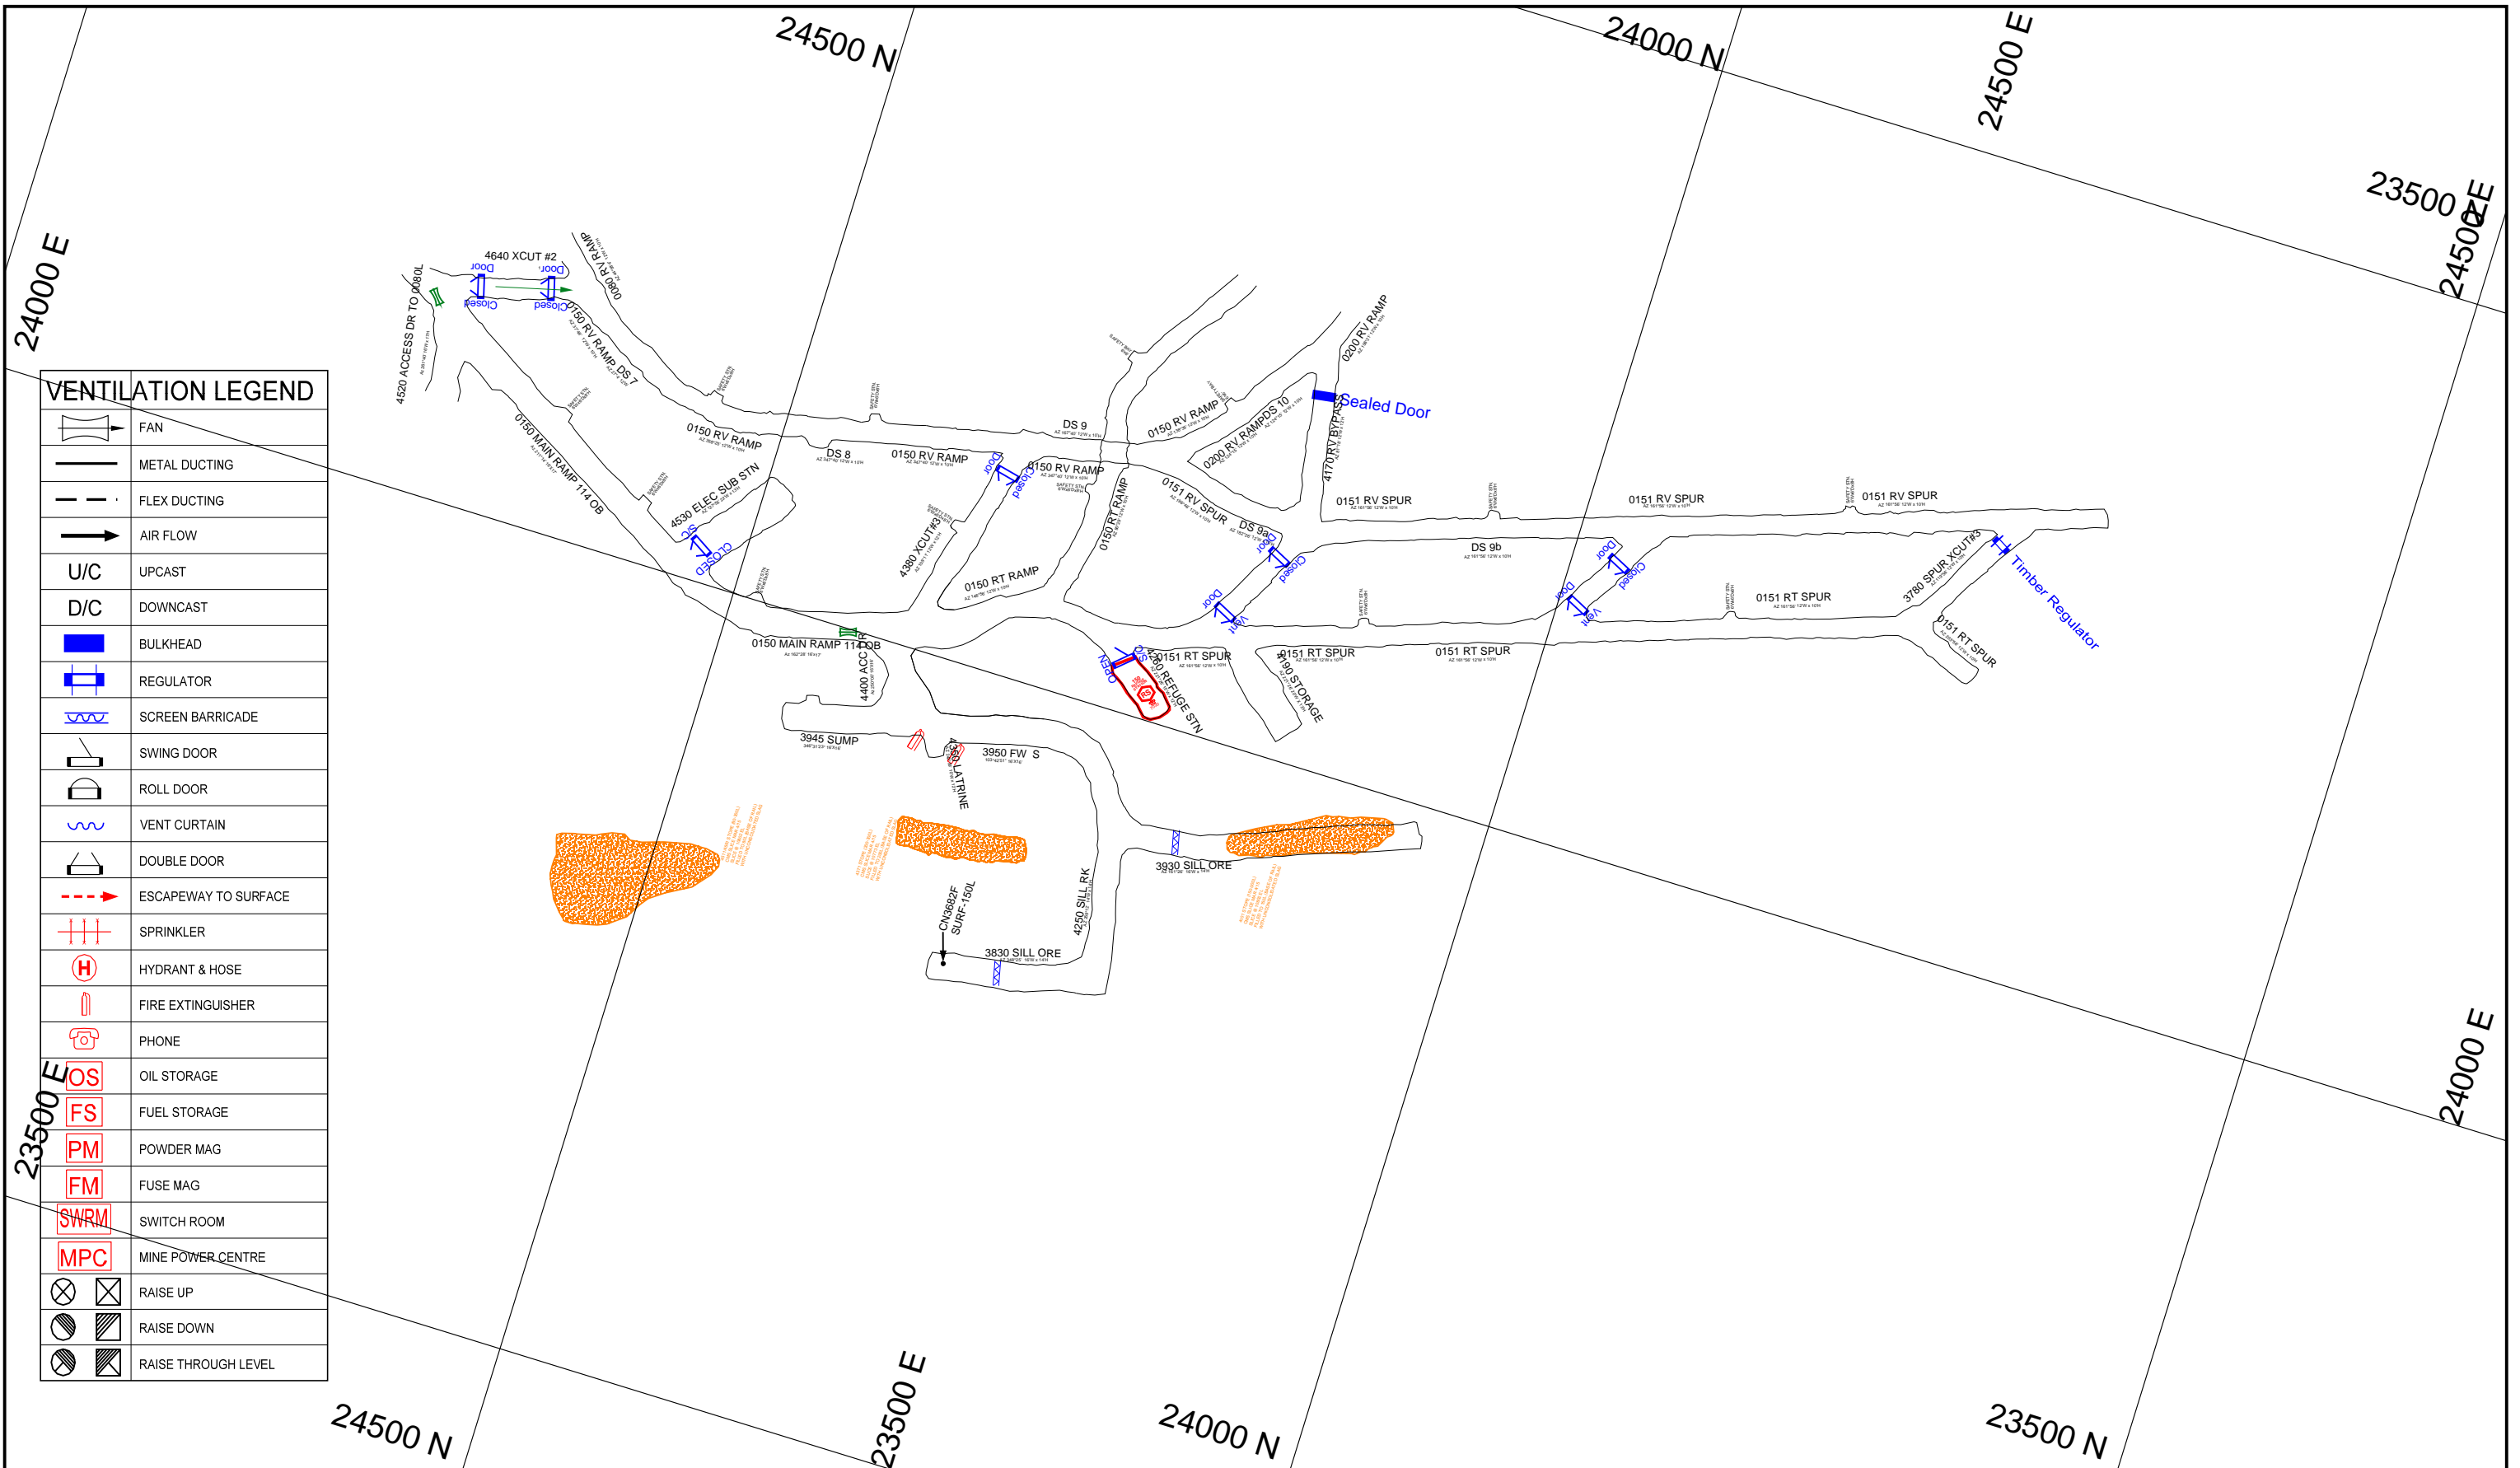

**VENTILATION LEGEND**


	FAN
	METAL DUCTING
	FLEX DUCTING
	AIR FLOW
	UPCAST
	D/CAST
	BULKHEAD
	REGULATOR
	SCREEN BARRICADE
	SWING DOOR
	ROLL DOOR
	VENT CURTAIN
	DOUBLE DOOR
	ESCAPEWAY TO SURFACE
	SPRINKLER
	HYDRANT & HOSE
	FIRE EXTINGUISHER
	PHONE
	OIL STORAGE
	FUEL STORAGE
	POWDER MAG
	FUSE MAG
	SWITCH ROOM
	MINE POWER CENTRE
	RAISE UP
	RAISE DOWN
	RAISE THROUGH LEVEL

REV.	DESCRIPTION	DATE	DWN BY	CHK'D BY	APP'D BY	ONTARIO OPERATIONS MINES ENGINEERING DEPARTMENT	REV.	MINE	114 OB	LEVEL	150L
1	May 2014 : Next Revision : Nov 2014	May 2014	rt				1	SUBJECT	Emergency (11x17)		
2	October 2014: Next Revision : April 2015	10/2015	VS			CHK'D		SCALE	1" = 100'	DRAWN BY	rt
						APP'D		CREATION DATE			05/02/2014
								FILENAME	VIEW_COPY_OF_V_22_114_0150.vdcl		



### VENTILATION LEGEND

	FAN
	METAL DUCTING
	FLEX DUCTING
	AIR FLOW
	UPCAST
	DOWNCAST
	BULKHEAD
	REGULATOR
	SCREEN BARRICADE
	SWING DOOR
	ROLL DOOR
	VENT CURTAIN
	DOUBLE DOOR
	ESCAPEWAY TO SURFACE
	SPRINKLER
	HYDRANT & HOSE
	FIRE EXTINGUISHER
	PHONE
	OIL STORAGE
	FUEL STORAGE
	POWDER MAG
	FUSE MAG
	SWITCH ROOM
	MINE POWER CENTRE
	RAISE UP
	RAISE DOWN
	RAISE THROUGH LEVEL

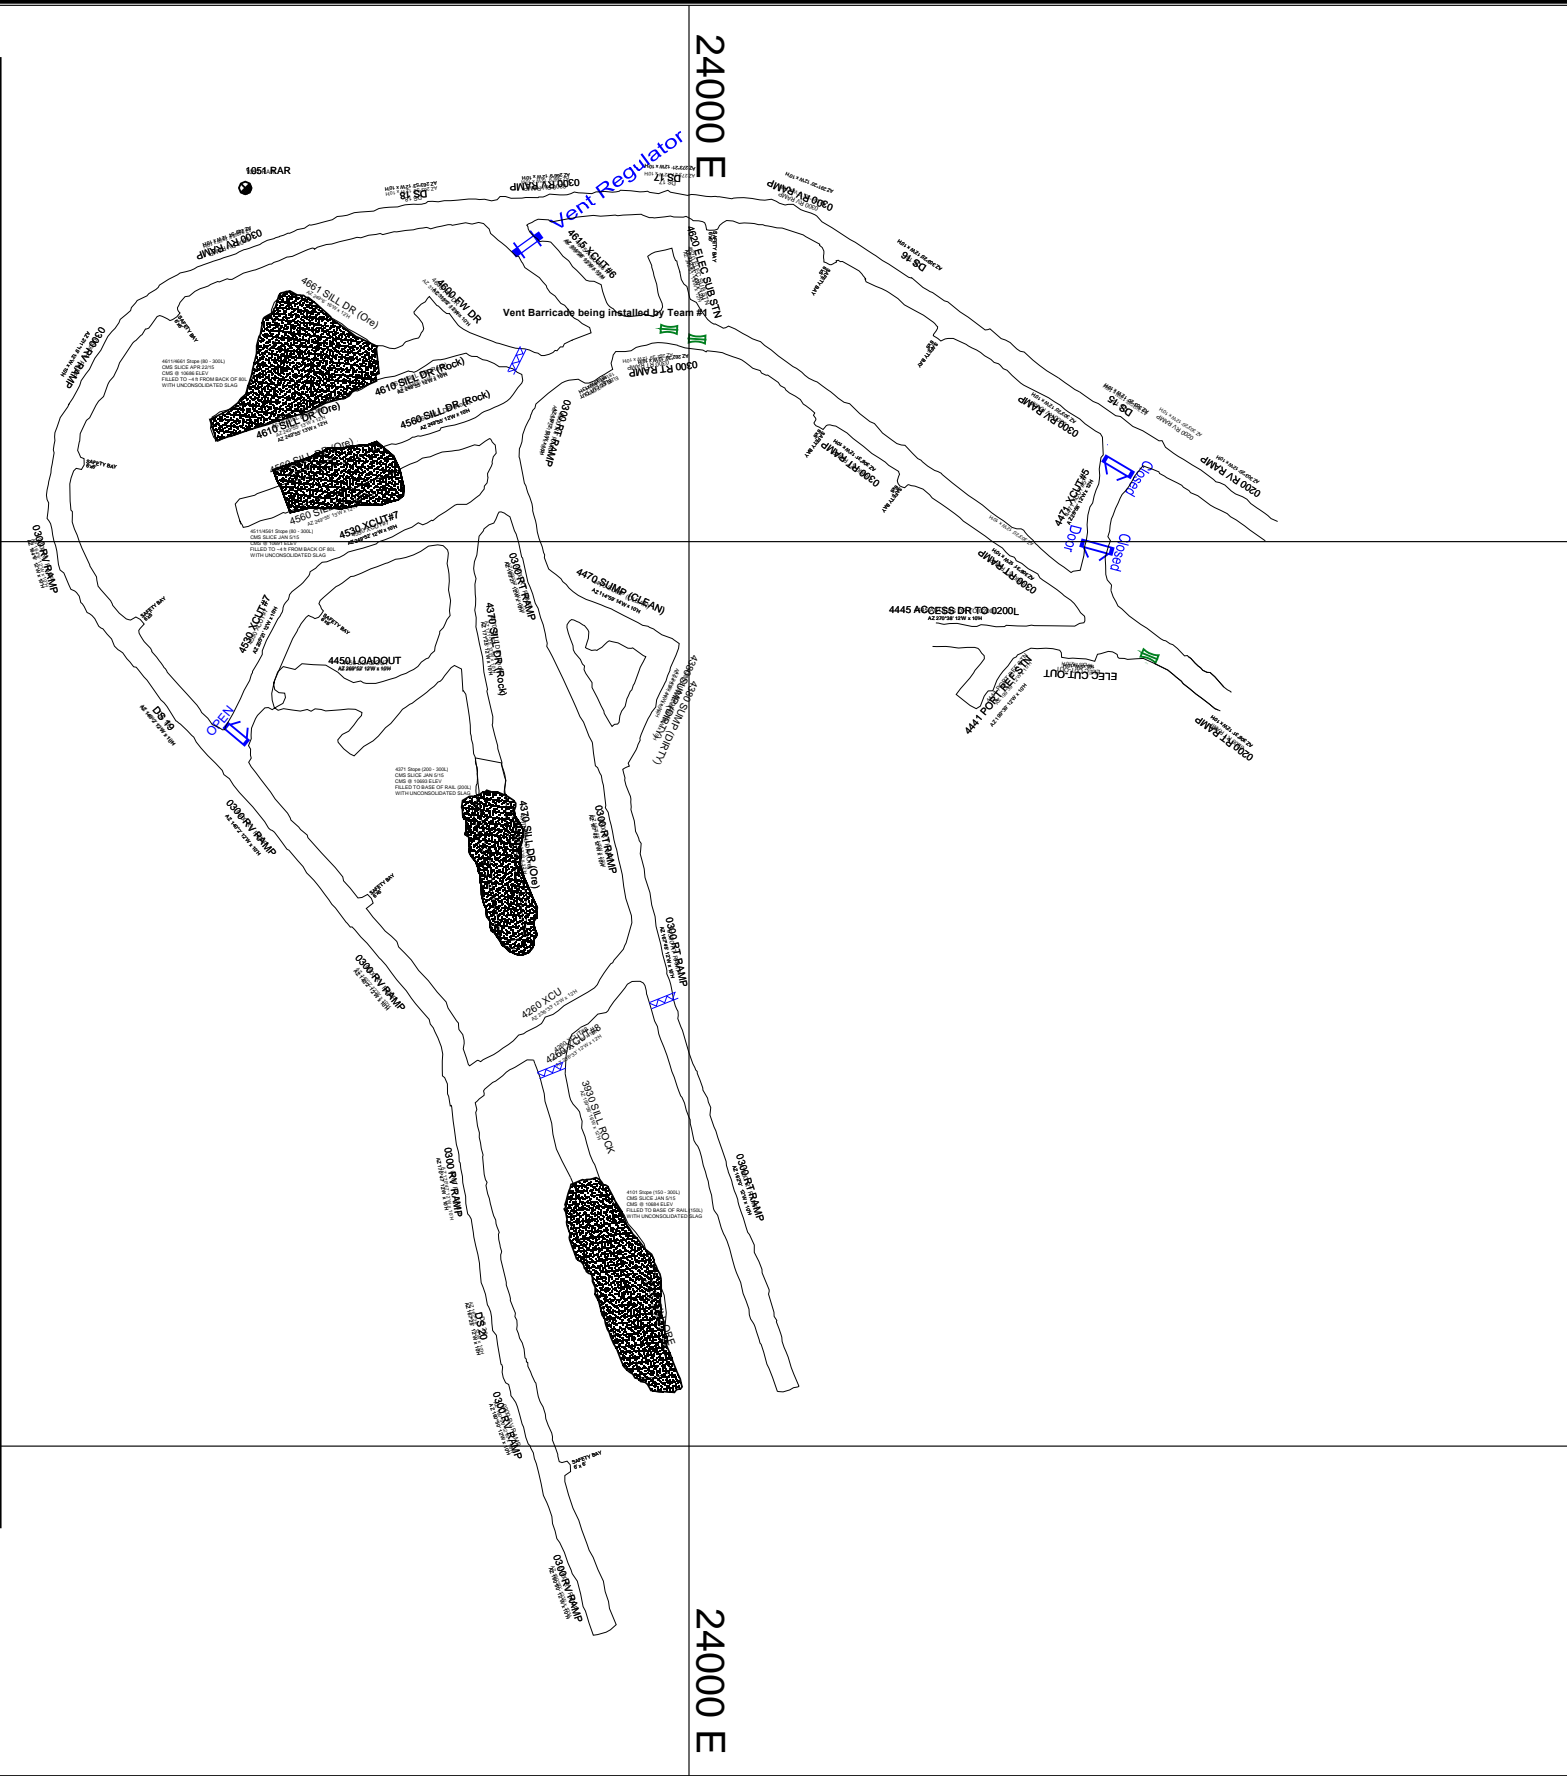

REV	DESCRIPTION	DATE	DWN BY	CHK'D BY	APP'D BY	ONTARIO OPERATIONS MINES ENGINEERING DEPARTMENT	REV.	MINE <u>114 OB</u> LEVEL <u>300 LEVEL</u>
1	May 2014 : Next Revision : Nov 2014	May 2014	rt				1	SUBJECT <u>Emergency (11x17)</u>
2	October 2014: Next Revision: April 2015	10/2015	VS				SCALE <u>1" = 100'</u> DRAWN BY <u>KB</u> CREATION DATE <u>12/05/2012</u>	
						CHK'D	APP'D	FILENAME <u>VIEW_COPY_OF_V_22_114_0300.vdcl</u>